
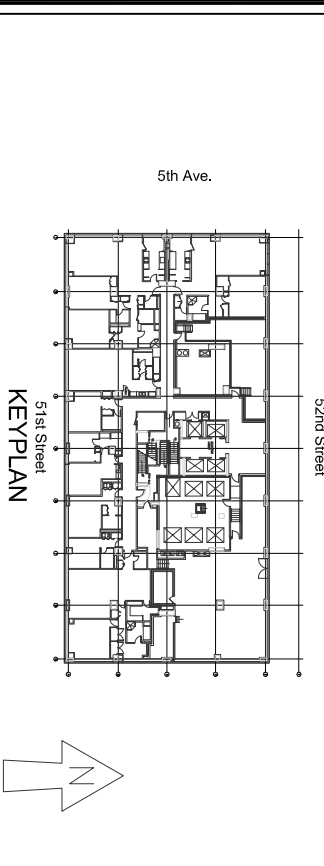


**Lilker Associates**

1001 Avenue of the Americas  
 New York, NY 10018  
 tel 212.695.1000  
 fax 212.695.1299  
 www.lilker.com

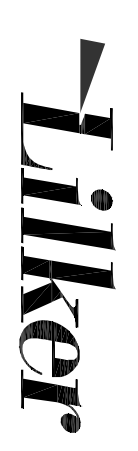

23RD THRU 48TH FLOOR MECHANICAL PLAN  
 SCALE: 3/8" = 1'-0"

- GENERAL NOTES:**
1. THE PLANS ARE INTENDED TO INDICATE THE GENERAL LOCATION AND FAN COIL UNIT TYPE IN EACH APARTMENT. EXACT UNIT DIMENSIONS, LOCATIONS, & RISER PIPING ARRANGEMENTS MUST BE VERIFIED BY THE INSTALLING CONTRACTOR.
  2. SEE FAN COIL UNIT SCHEDULE FOR UNIT CAPACITIES.
  3. SEE TYPICAL FAN COIL UNIT INSTALLATION DETAIL (DWG M-6) FOR INSTALLATION REQUIREMENTS.

THIS PLAN IS APPROVED ONLY FOR WORK INDICATED ON THE APPLICATION SPECIFICATION SHEET. ALL OTHER MATTERS SHOWN ARE NOT TO BE RELEIED UPON, OR TO BE CONSIDERED AS EITHER BEING APPROVED OR IN ACCORDANCE WITH APPLICABLE CODES.

NO.	ROOM RENAME	DATE	BY
1		06-17-2010	VR

PROJECT #: 01961  
 DATE: 10-10-07  
 SCALE: 3/8" = 1'-0"  
 DESIGNED BY:  
 DRAWN BY: DW  
 REVIEWED BY: VR  
 APPROVED BY:

PROJECT TITLE:  
 OLYMPIC TOWER  
 FAN COIL  
 REPLACEMENT

DRAWING TITLE:  
 23RD THRU 48TH FLOOR  
 MECHANICAL PLAN

DRAWING NO.  
 M-2